



Filename: \\utari.com\share2\ASND\Projects\Projects\111242 - Halfway House Water Upgrade - Mechanical.dwg

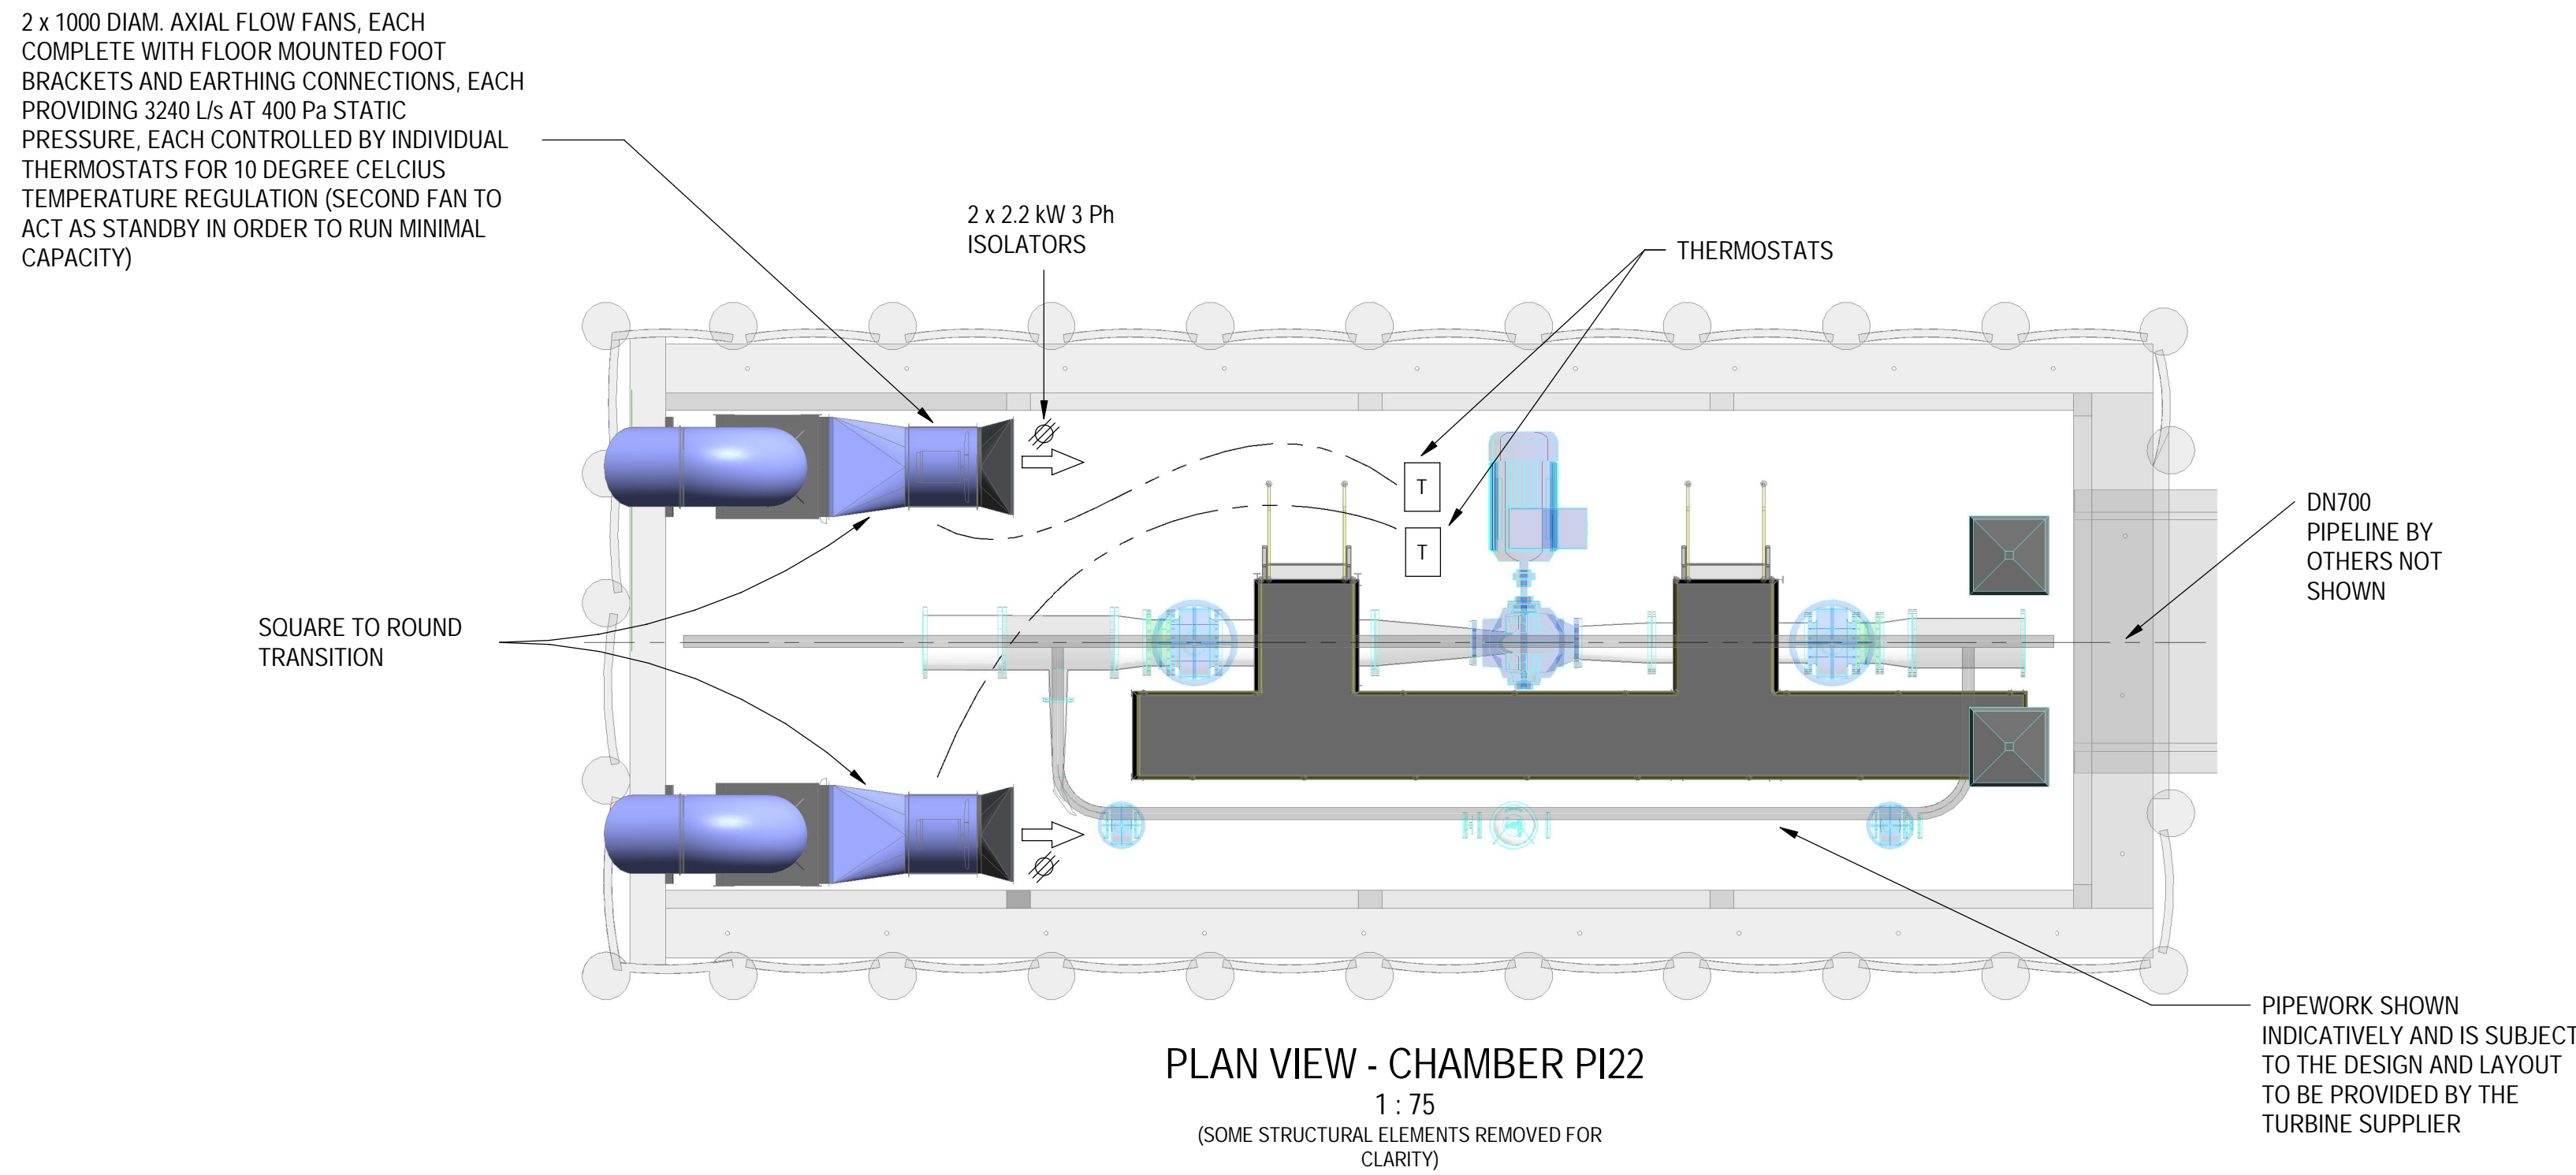


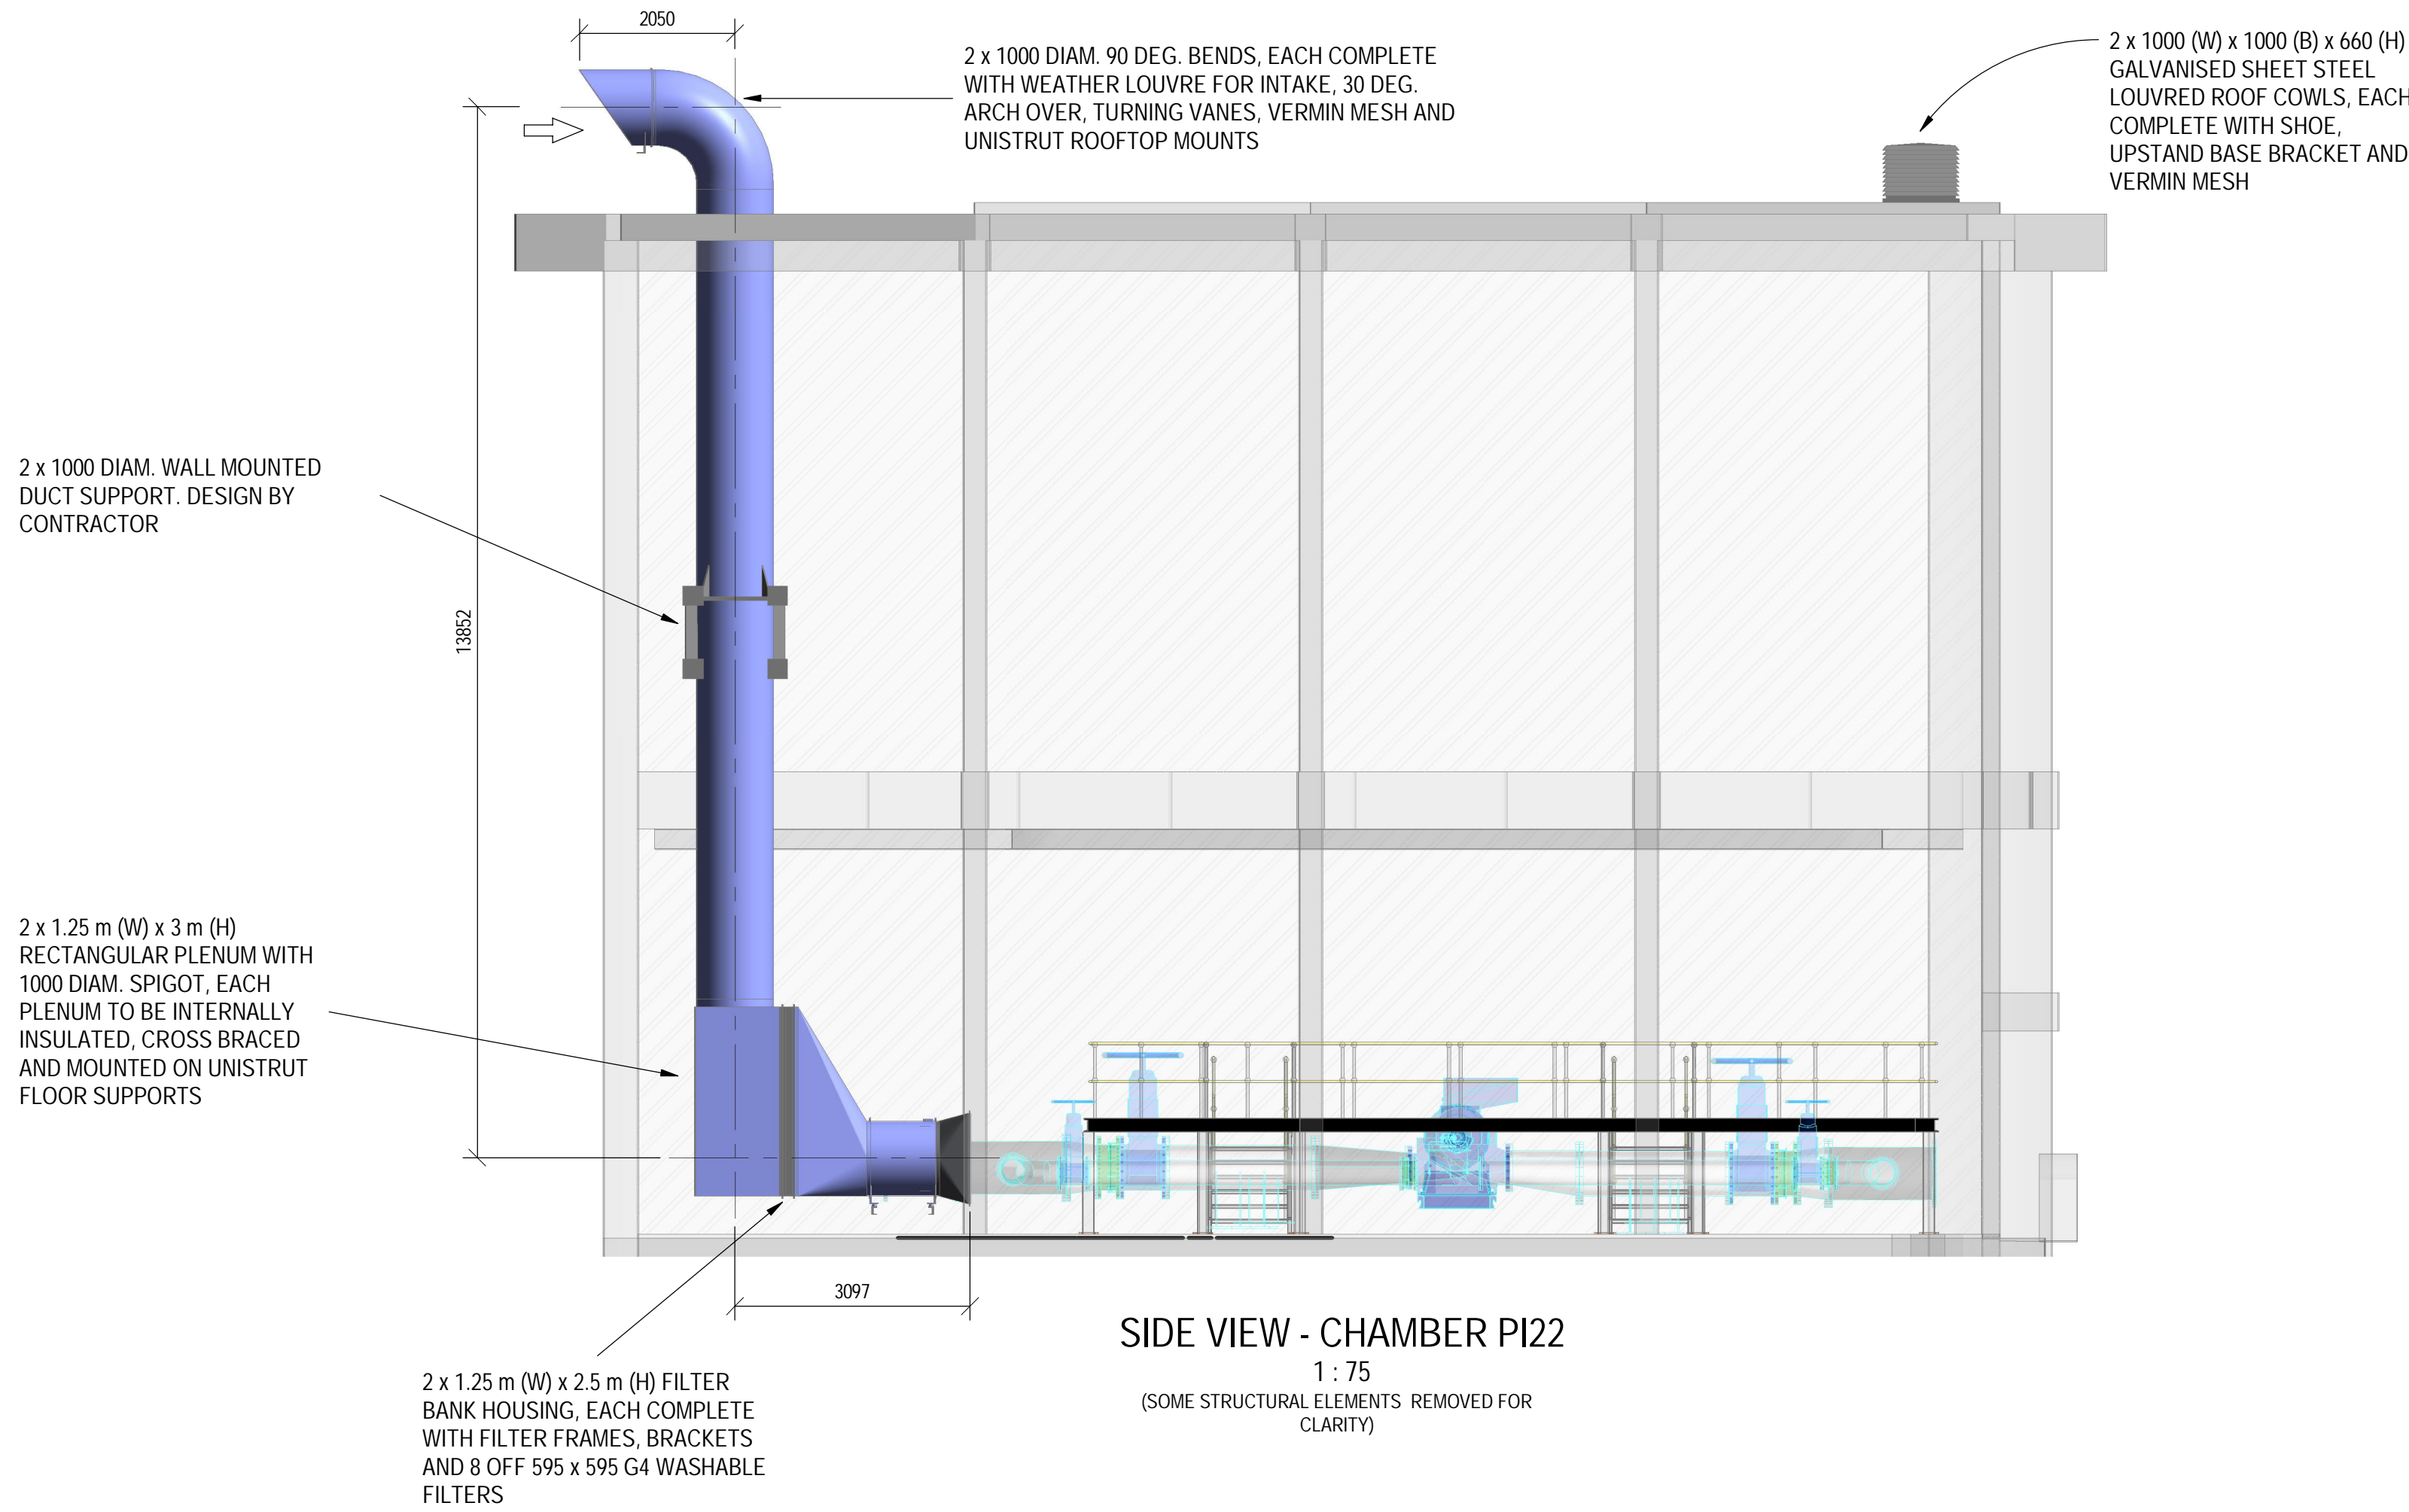

AIR TERMINAL SCHEDULE			
REF	TYPE	SIZE	QTY
SAG-01	DOUBLE DEFLECTION AIR GRILLE	1200 x 1200	4
WL-01	WEATHER LOUVRE C/W VERMIN MESH	1000 DIAM.	4
RAG-01	LOUVRED ROOF COWL C/W VERMIN MESH	1000 x 1000 x 660	2

FAN SCHEDULE							
REF	SIZE	DESCRIPTION	AIR FLOW	STATIC PRESSURE	THRUST	RATED POWER	QTY
VR-SF01	1000 DIAM.	AXIAL FLOW FAN	3.24 m³/s	200 - 400 Pa	-	2.2 kW	2
VR-SF02	400 DIAM.	JET FAN	2.00 m³/s	-	20 N	1.5 kW	3
VR-SF03	1000 DIAM.	AXIAL FLOW FAN	3.24 m³/s	200 Pa	-	2.2 kW	2

FILTER BANK SCHEDULE					
REF	TYPE	FRAME SIZE	PANEL QTY	FILTER SIZE	FRAME QTY
FLT-01	G4 WASHABLE OR SIMILAR APPROVED	1250 x 2500	2	595 x 595	8

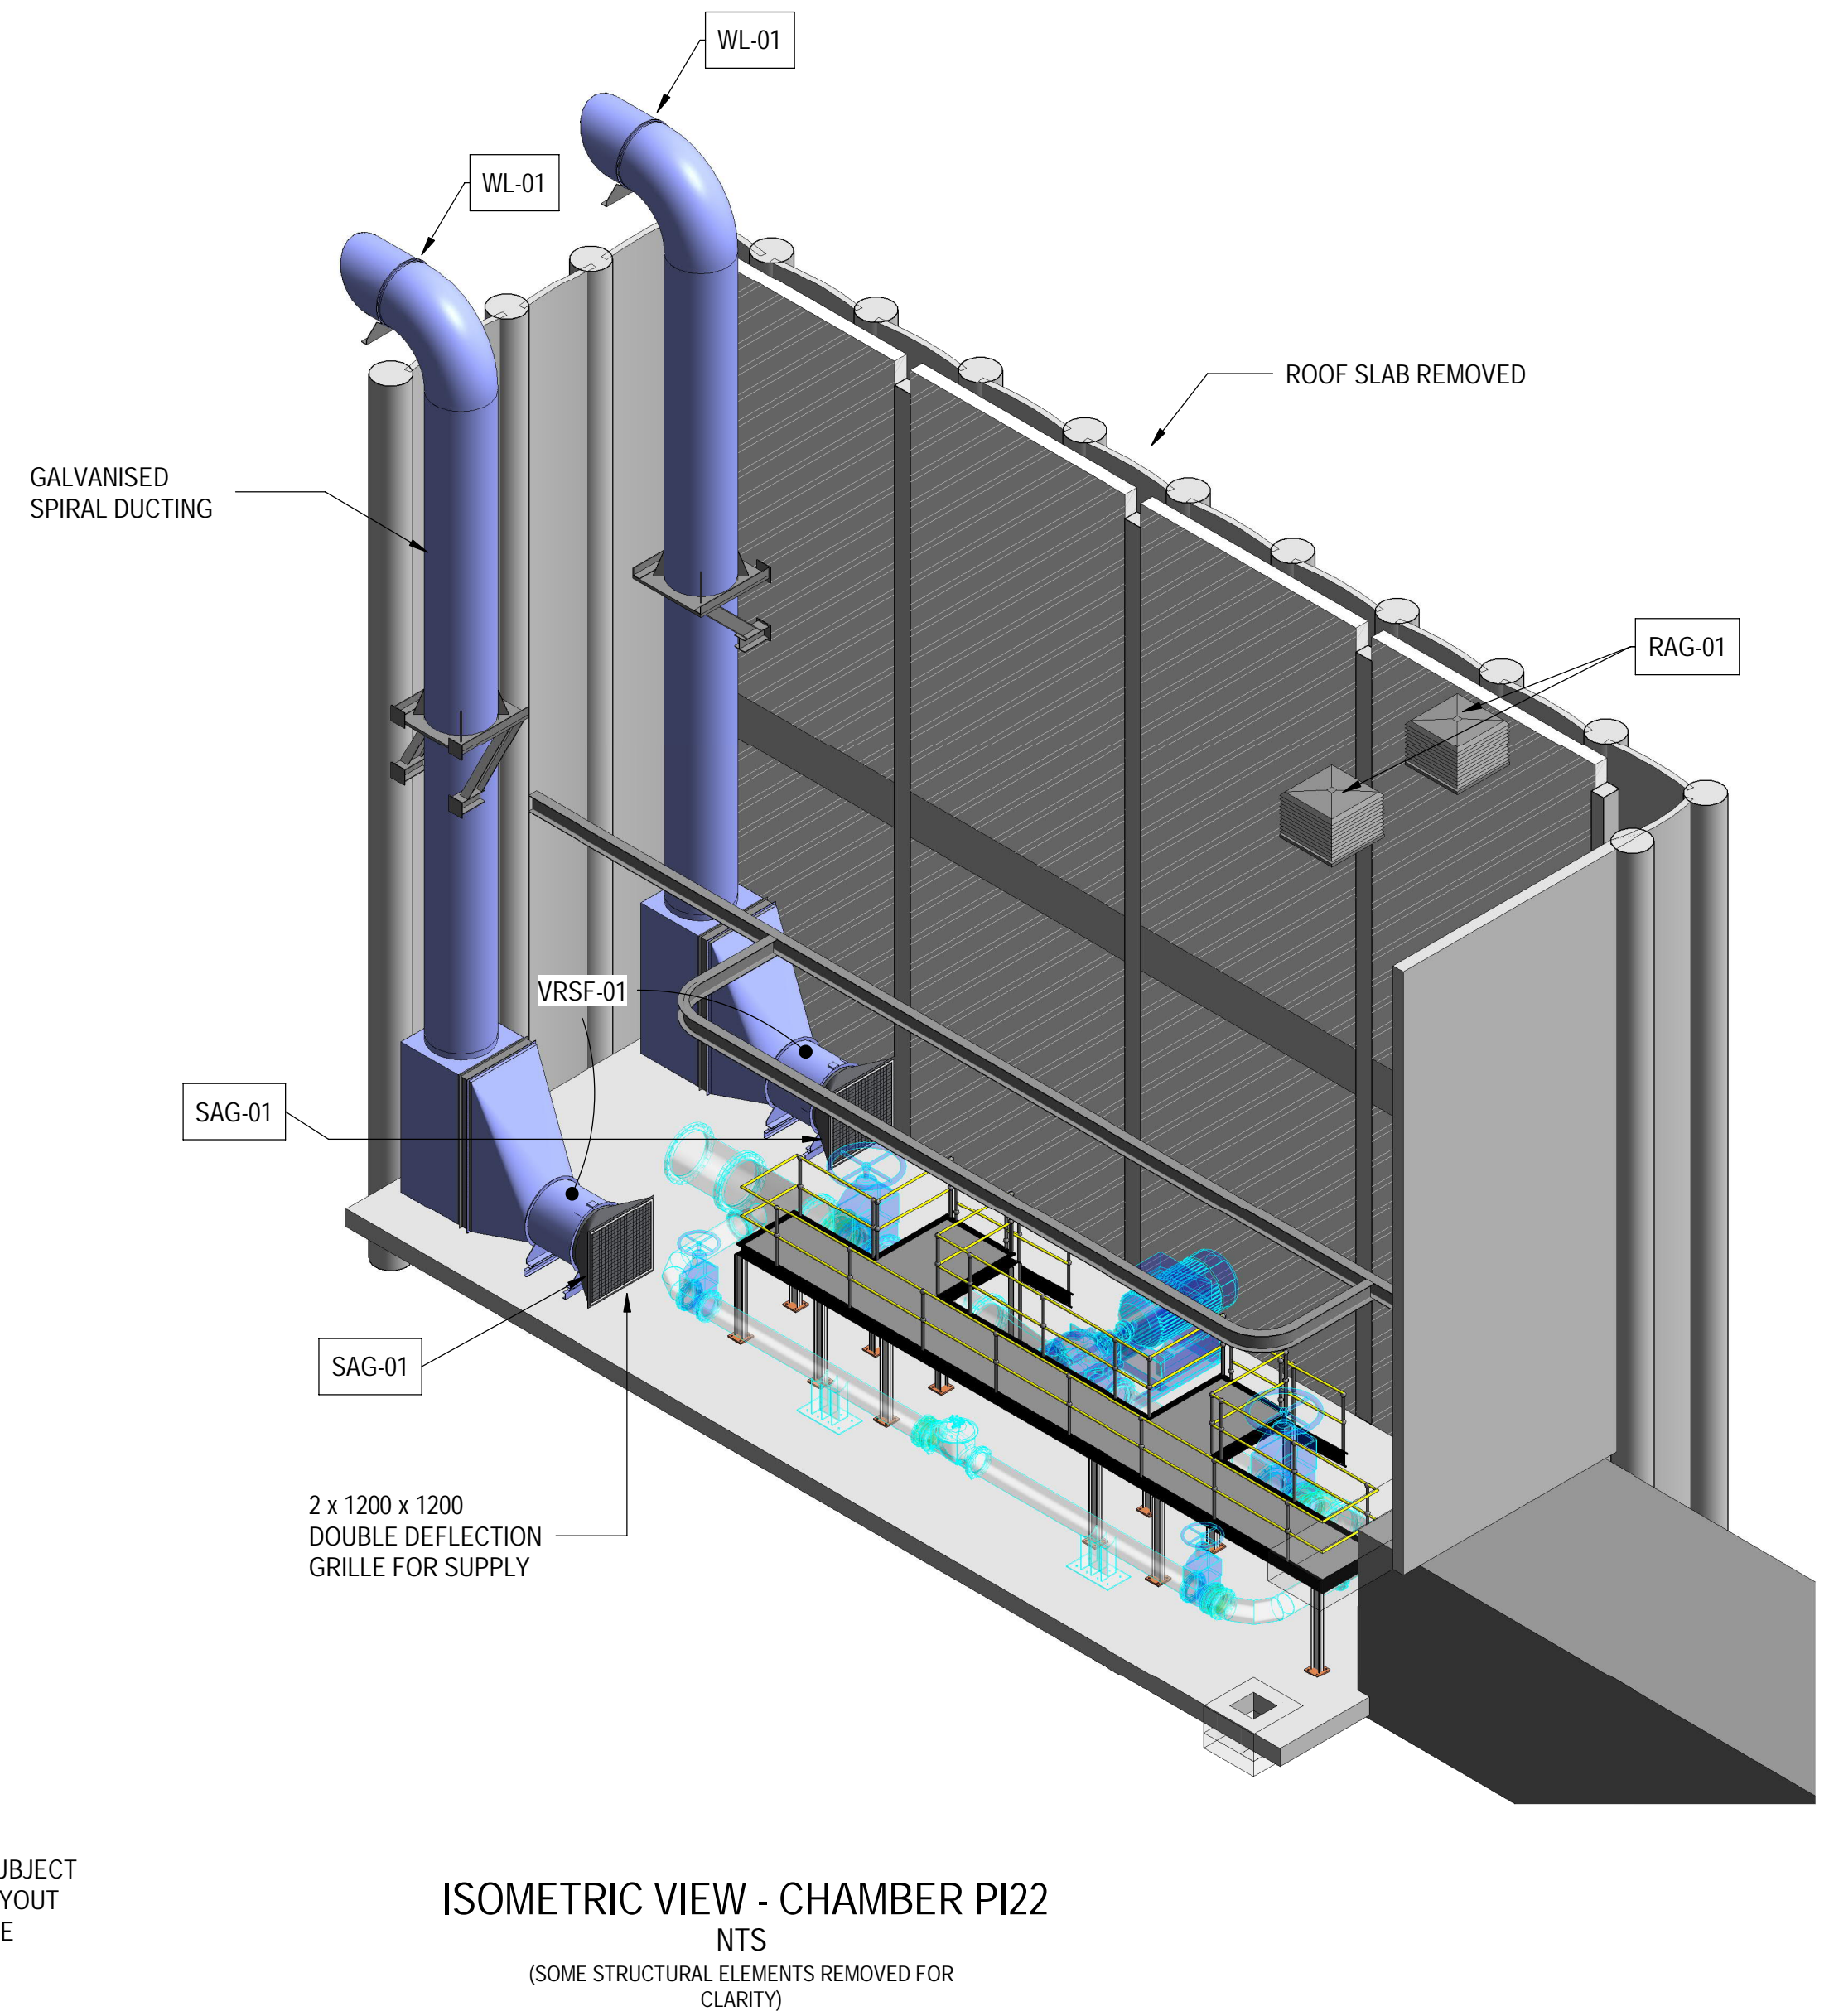- GENERAL NOTES**
- THIS DRAWING SHALL BE READ IN CONJUNCTION WITH ALL OTHER CONTRACT DOCUMENTATION
 - DO NOT SCALE THESE DRAWINGS
 - ALL DIMENSIONS IN MILLIMETERS UNLESS OTHERWISE NOTED
 - THE DIMENSIONS SHOWN ARE INDICATIVE AND THE CONTRACTOR SHALL VERIFY ALL DIMENSIONS ON SITE
 - REFER TO SCHEDULE ON SHEET 0516



CONSULTING ENGINEERS ZUTARI IMPACT. ENGINEERED. 32A JELLOOE AVENUE OXFORD CORNER ROSEBANK SOUTH AFRICA TEL: +27 11 214 4500	DESIGNED	S.C.	20.10.21
	DRAWN	S.C.	20.10.21
	CHECKED	M.B.	20.10.21
	APPROVED BY:	S.R.	
		SIGNATURE	DATE
CLIENT 17 HARRISON STREET MARSHALLTOWN 2107	ECSA REG. No.		
	CHECKED BY:		
		SIGNATURE	DATE
	ECSA REG. No.		
 Johannesburg Water		17 HARRISON STREET MARSHALLTOWN 2107 TEL: (011) 688-1400 FAX: (011) 688-1529	
		 HALFWAY HOUSE RESERVOIR ACCESS CHAMBERS VENTILATION SHEET 1 OF 3	
APPROVAL BY JW DEPOT		SCALE	AMENDMENTS
CHECKED		AS SHOWN	REV: DESCRIPTION DATE:
APPROVED BY:			TO FOR TENDER XX.10.21
	SIGNATURE	DATE	
APPROVAL BY JW PLANNING			
CHECKED			
APPROVED BY:			
	SIGNATURE	DATE	
DRAWING No.		PROJECT No.	
111242 - 0000-DRG-WW-0516 - T0		DRAWING No.	
A1		SHEET 1 OF 3	
ORIGINAL PAGE SIZE		FILE No.	