


FLOOR PLAN LAYOUT
SCALE 1: 50

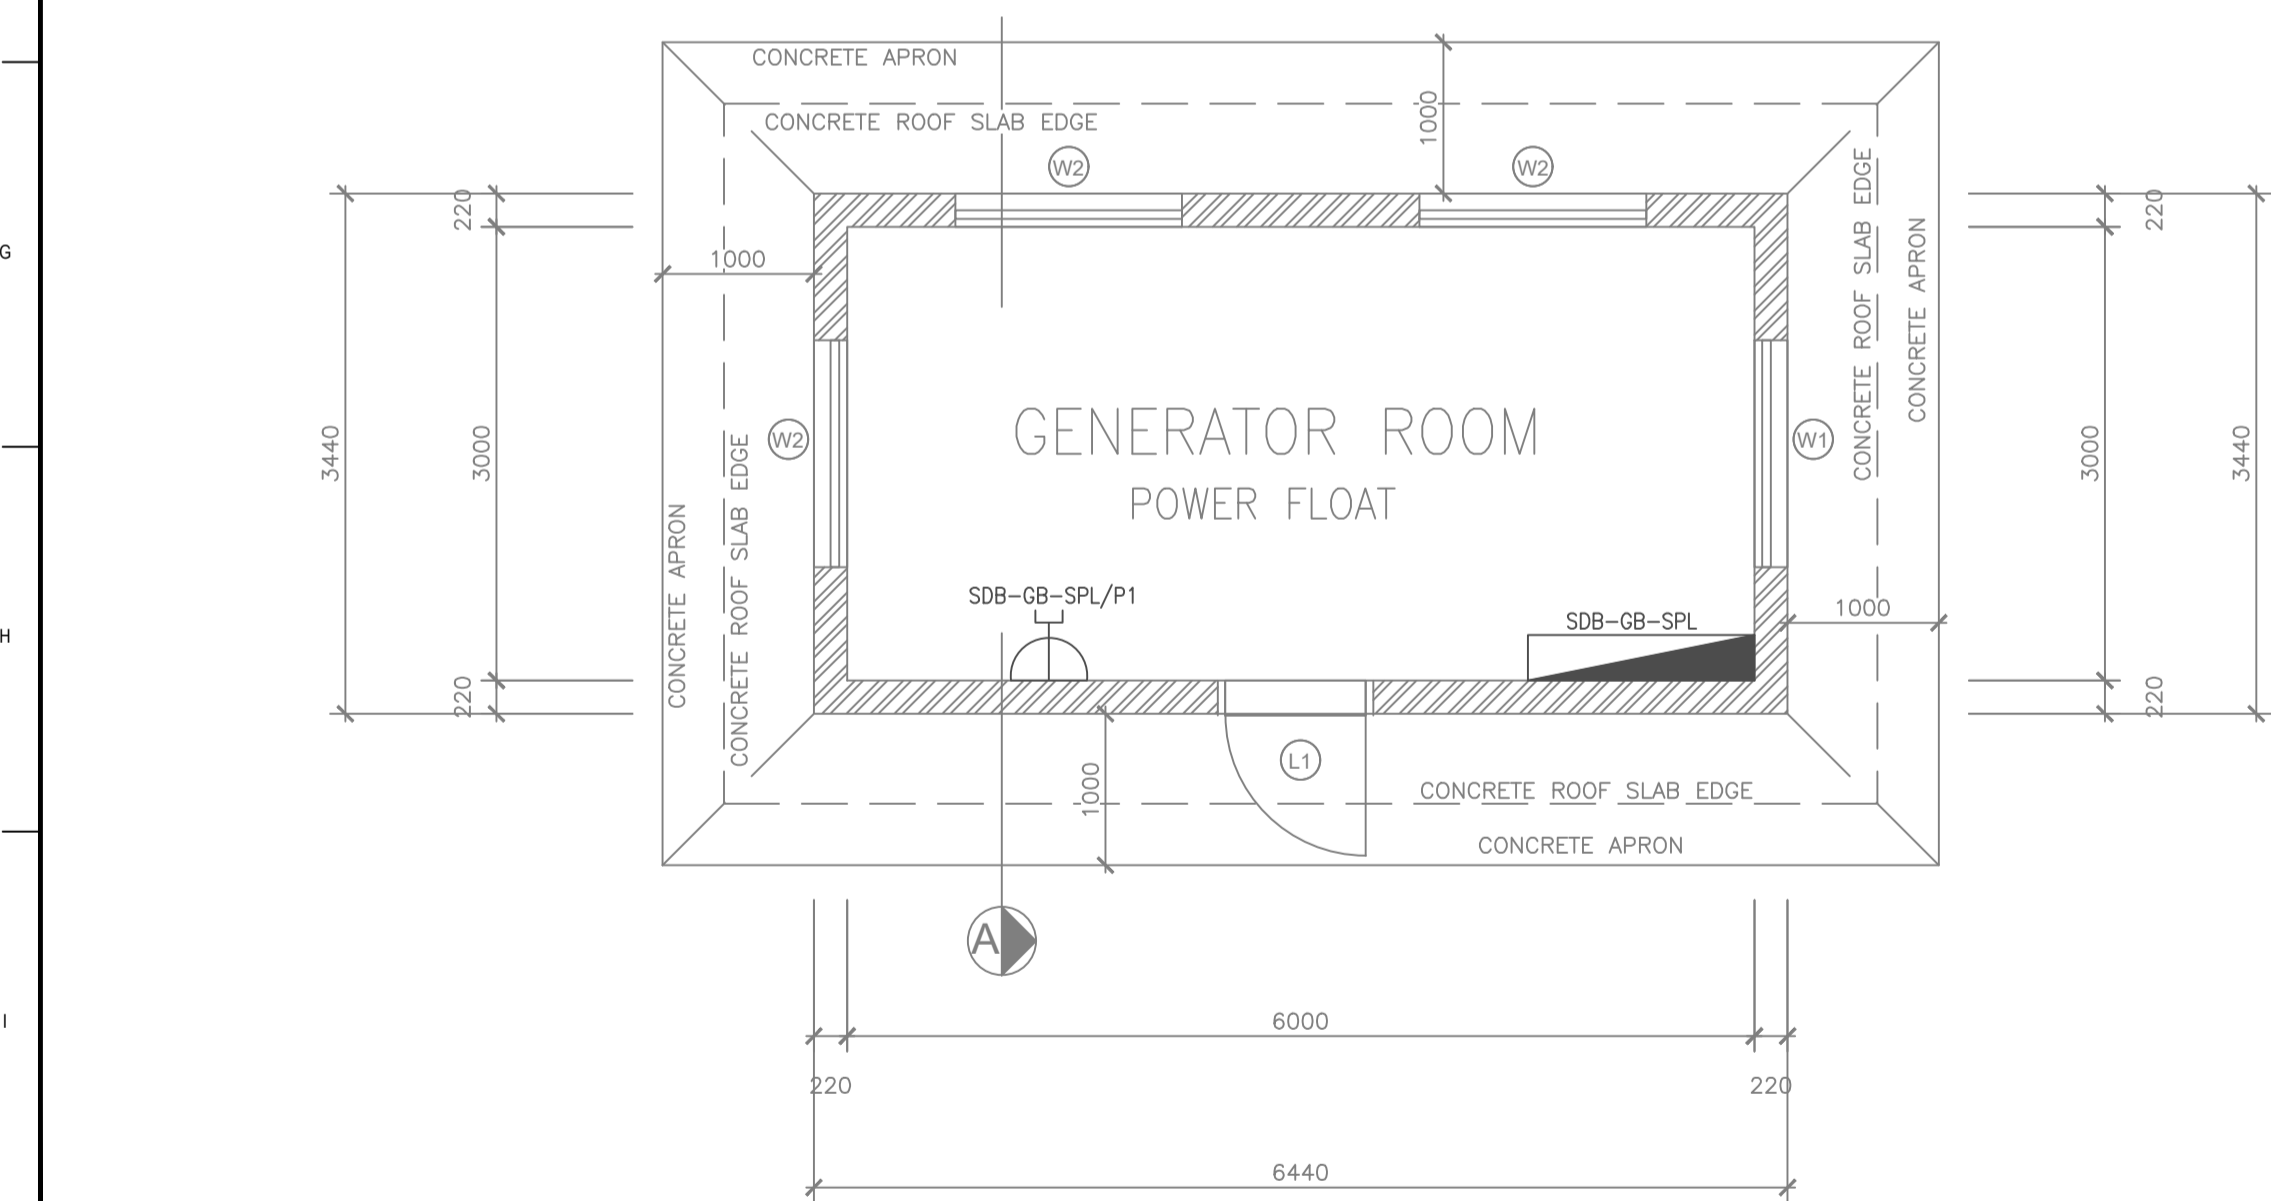

FLOOR LAYOUT PLAN
SCALE 1: 50

ELECTRICAL LEGEND

	DISTRIBUTION BOARD
	BEKA VAPOURLINE: IK08 IP65 46W VLN LED STANDARD VERSION 7352LM 4000K BODY & DIFFUSER IN HIGH IMPACT POLYCARBONATE WITH SS CLIPS & BRACKETS
	BEKA VAPOURLINE: IK08 IP65 46W VLN LED EMERGENCY VERSION 7992/810 (EM) LM BODY & DIFFUSER IN HIGH IMPACT POLYCARBONATE WITH SS CLIPS & BRACKETS
	BEKA LEDNOVA: IK07 IP66 70W MIDI STANDARD VERSION 8704LM 4000K, BODY IN MARINE GRADE ALUMINIUM & POLYCARBONATE DIFFUSER, SUITABLE FOR WALL MOUNTING
	1 LEVER 1 WAY METAL CLAD LIGHT SWITCH
	PHOTO-ELECTRIC CELL IN IP65 CLEAR ENCLOSURE
	DOUBLE SWITCHED METAL CLAD SOCKET OUTLET IN WEATHER-PROOF ENCLOSURE
	SINGLE PHASE IP65 INDUSTRIAL WELDING SOCKET
	THREE PHASE IP65 INDUSTRIAL WELDING SOCKET

Engineer:

KEON
CONSULTING ENGINEERS
TECHNO
DESIGNS

Civil Structural & Transport Engineers

Client:

Johannesburg Water

JOHANNESBURG WATER

Turkine Hall,
65 Wami Pillar Street,
Newtown, Johannesburg

THESE NOTES SERVE AS AN ADDENDUM TO THE SPECIFICATION IN THE BILL OF QUANTITIES (BOQ). IN THOSE CASES WHERE THE BOQ SPECIFICATIONS DIFFER FROM THESE NOTES, THESE NOTES SHALL TAKE PRECEDENCE.

ON ORIGINAL

Engineer:
F. Machwenyika Pr Eng (20140463)

Drawn By:
A. Moodley

Designed By:
F. Machwenyika

Checked By:
L. Makanza

Signature:
Date: August 2022

Signature:
Date: August 2022

Signature:
Date: August 2022

ELECTRICAL NOTES:
1.0

Refer To Drawing No:

Key Plan:

TO	31-08-2023	ISSUED FOR TENDER	BM	FM
No	Date	Details	Chd	Appd
		Revisions		

Project: JW14406 - LINBRO PARK PUMP STATION & TOWER

Description: ELECTRICAL SMALL POWER AND LIGHTING DESIGN - PLUGS

Issued For: TENDER

Size:	Scale:	Sheet No:	Original Date:
A1	As Shown	1 OF 1	February 2022

Project No:	Drawing No:	Revision:
C01486	EM-005	T0