


MAIN KIOSK

GUARD HOUSE DISTRIBUTION BOARD DB-GH



DIEPSLOOT SEWER PIPE AND  
BRIDGE REPAIRS

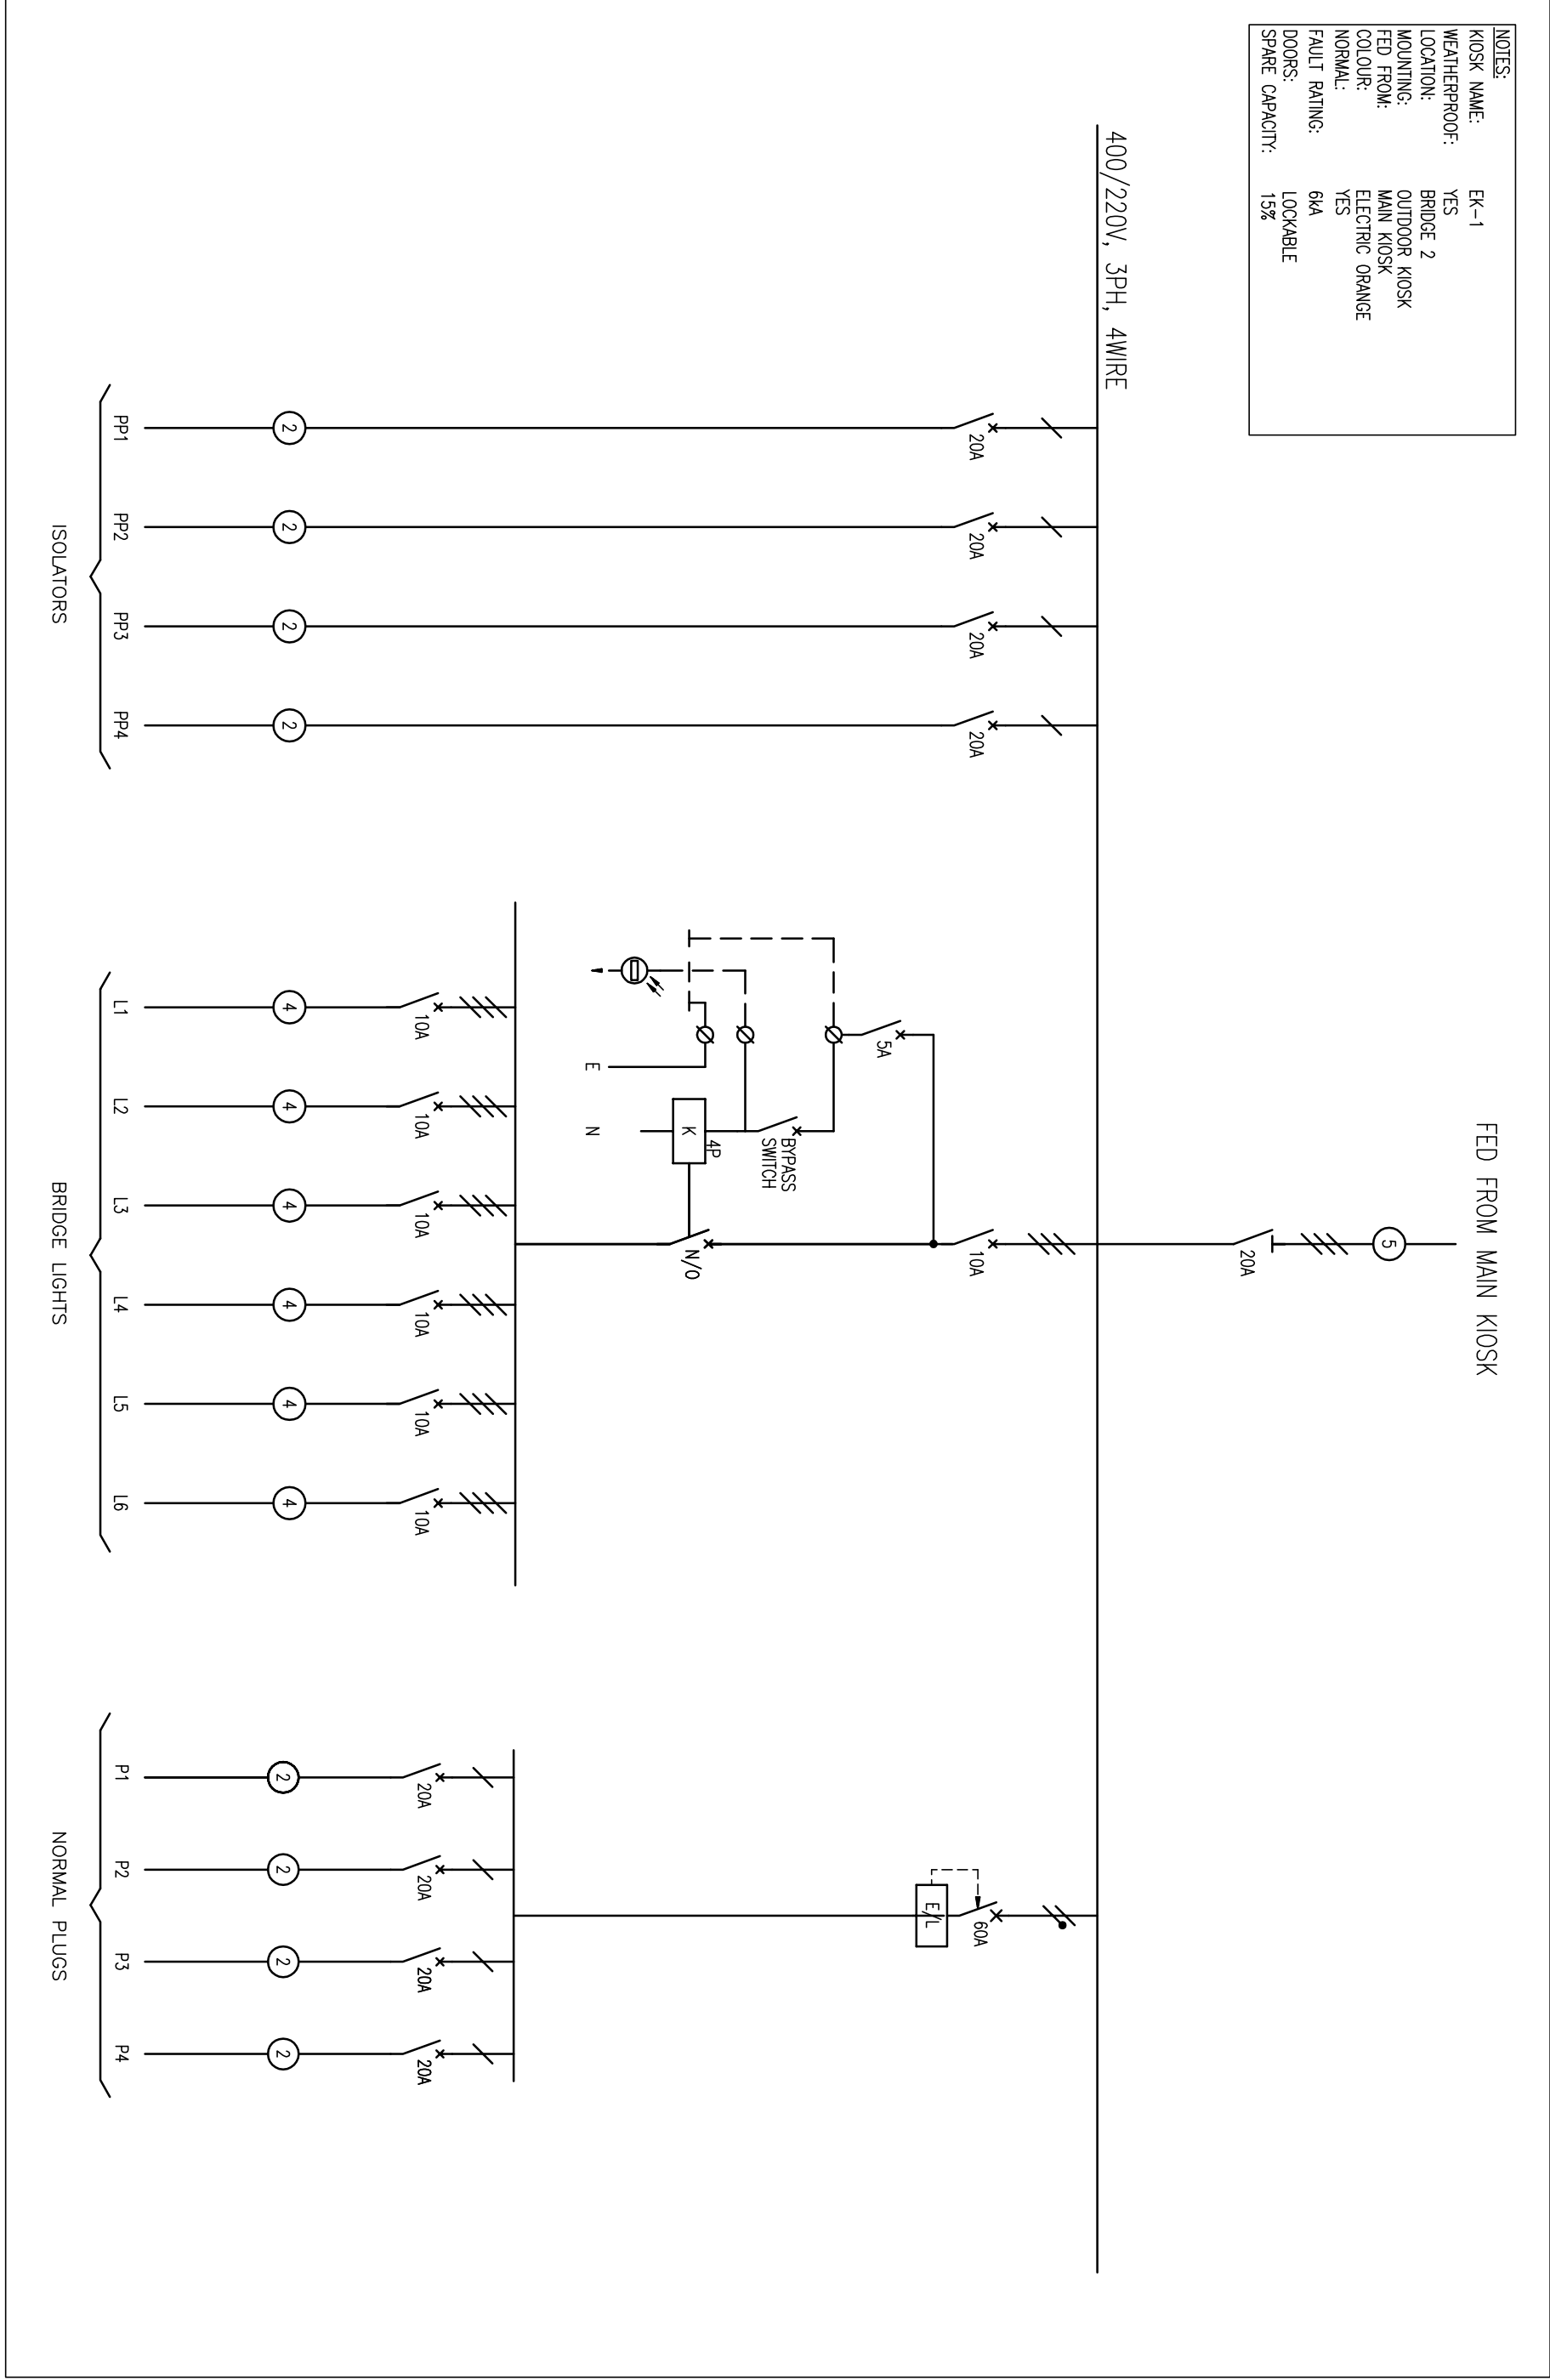

MAIN KIOSK, DB-GH AND EK-2  
SINGLE LINE DIAGRAMS

SCALE	NTS	DESIGN/DRAWN	N.B.M	DRAWN DATE	10/10/2018
CHECKED BY	T.G.M	ISSUE DATE			
DRAWING NUMBER	13247/02/E/ELECT/712	REVISION	0		

ELECTRICAL KIOSK EK-1