



GROUND FLOOR PLAN  
SCALE 1:100

LEGEND

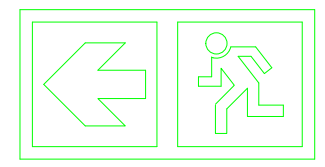

 
Photoluminescent  
Evacuation signage

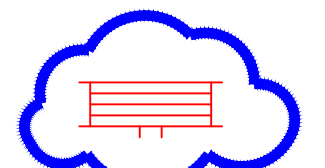

1X Fire Hose Reel & 2X  
Fire Extinguisher setup



Evacuation Direction



Fire Water Line



Fire Walls (120min)

EQUIPMENT SCHEDULE


Description	Type	Quantity
Fire Extinguisher	4,5 KG DCP	2
Fire Hose Reel	30m Hose, Wall mounted	1

NOTES

- DRAWING SHOWS POSITION OF FIRE FIGHTING EQUIPMENT
- ALL EQUIPMENT TO BE SERVICED AND REPAIRED ACCORDING TO SABS STANDARDS
- ALL FIRE SIGNAGE TO BE PHOTOLUMINESCENCE SIGNAGE
- PORTABLE EXTINGUISHERS TO HUNG ON PURPOSE MADE BOARDS AS INDICATED.
- PIPEWORK TO BE GALVANIZED STEEL
- ALL FIRE HOSE REELS TO BE 30M OF LENGTH C/W ALUMINIUM DISCHARGE NOZZLES  
HANDWHEEL ISOLATING SUPPLY VALVE, ROLLER GUIDE AND UNION COUPLING.

Client:

THESE NOTES SERVE AS AN ADDENDUM TO THE SPECIFICATION IN THE BILL OF MATERIALS (BOM). IN THOSE CASES WHERE THE BOM SPECIFICATIONS DIFFER FROM THESE NOTES, THESE NOTES SHALL TAKE PRECEDENCE.

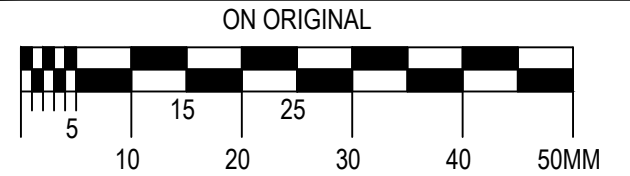

Engineer: L. Buxerimwe Ph.Eng	Designed By: T.M.	Checked By: L.B.
Drawn By: T.M.	Signature: [Signature]	Signature: [Signature]
Date: August 2024	Date: August 2024	Date: August 2024

Refer To Drawing No:


Key Plan:


Project:  
JW14468 - NEW OFFICES AT MIDRAND DEPOT

Description:  
Fire Services - Ground Floor

Issued For:  
TENDER

Size:	Scale:	Sheet No:	Original Date:
A1	As Shown	1 OF 1	JULY 2024

Project No:	Drawing No:	Revision:
JW14468	ME-F02	0